


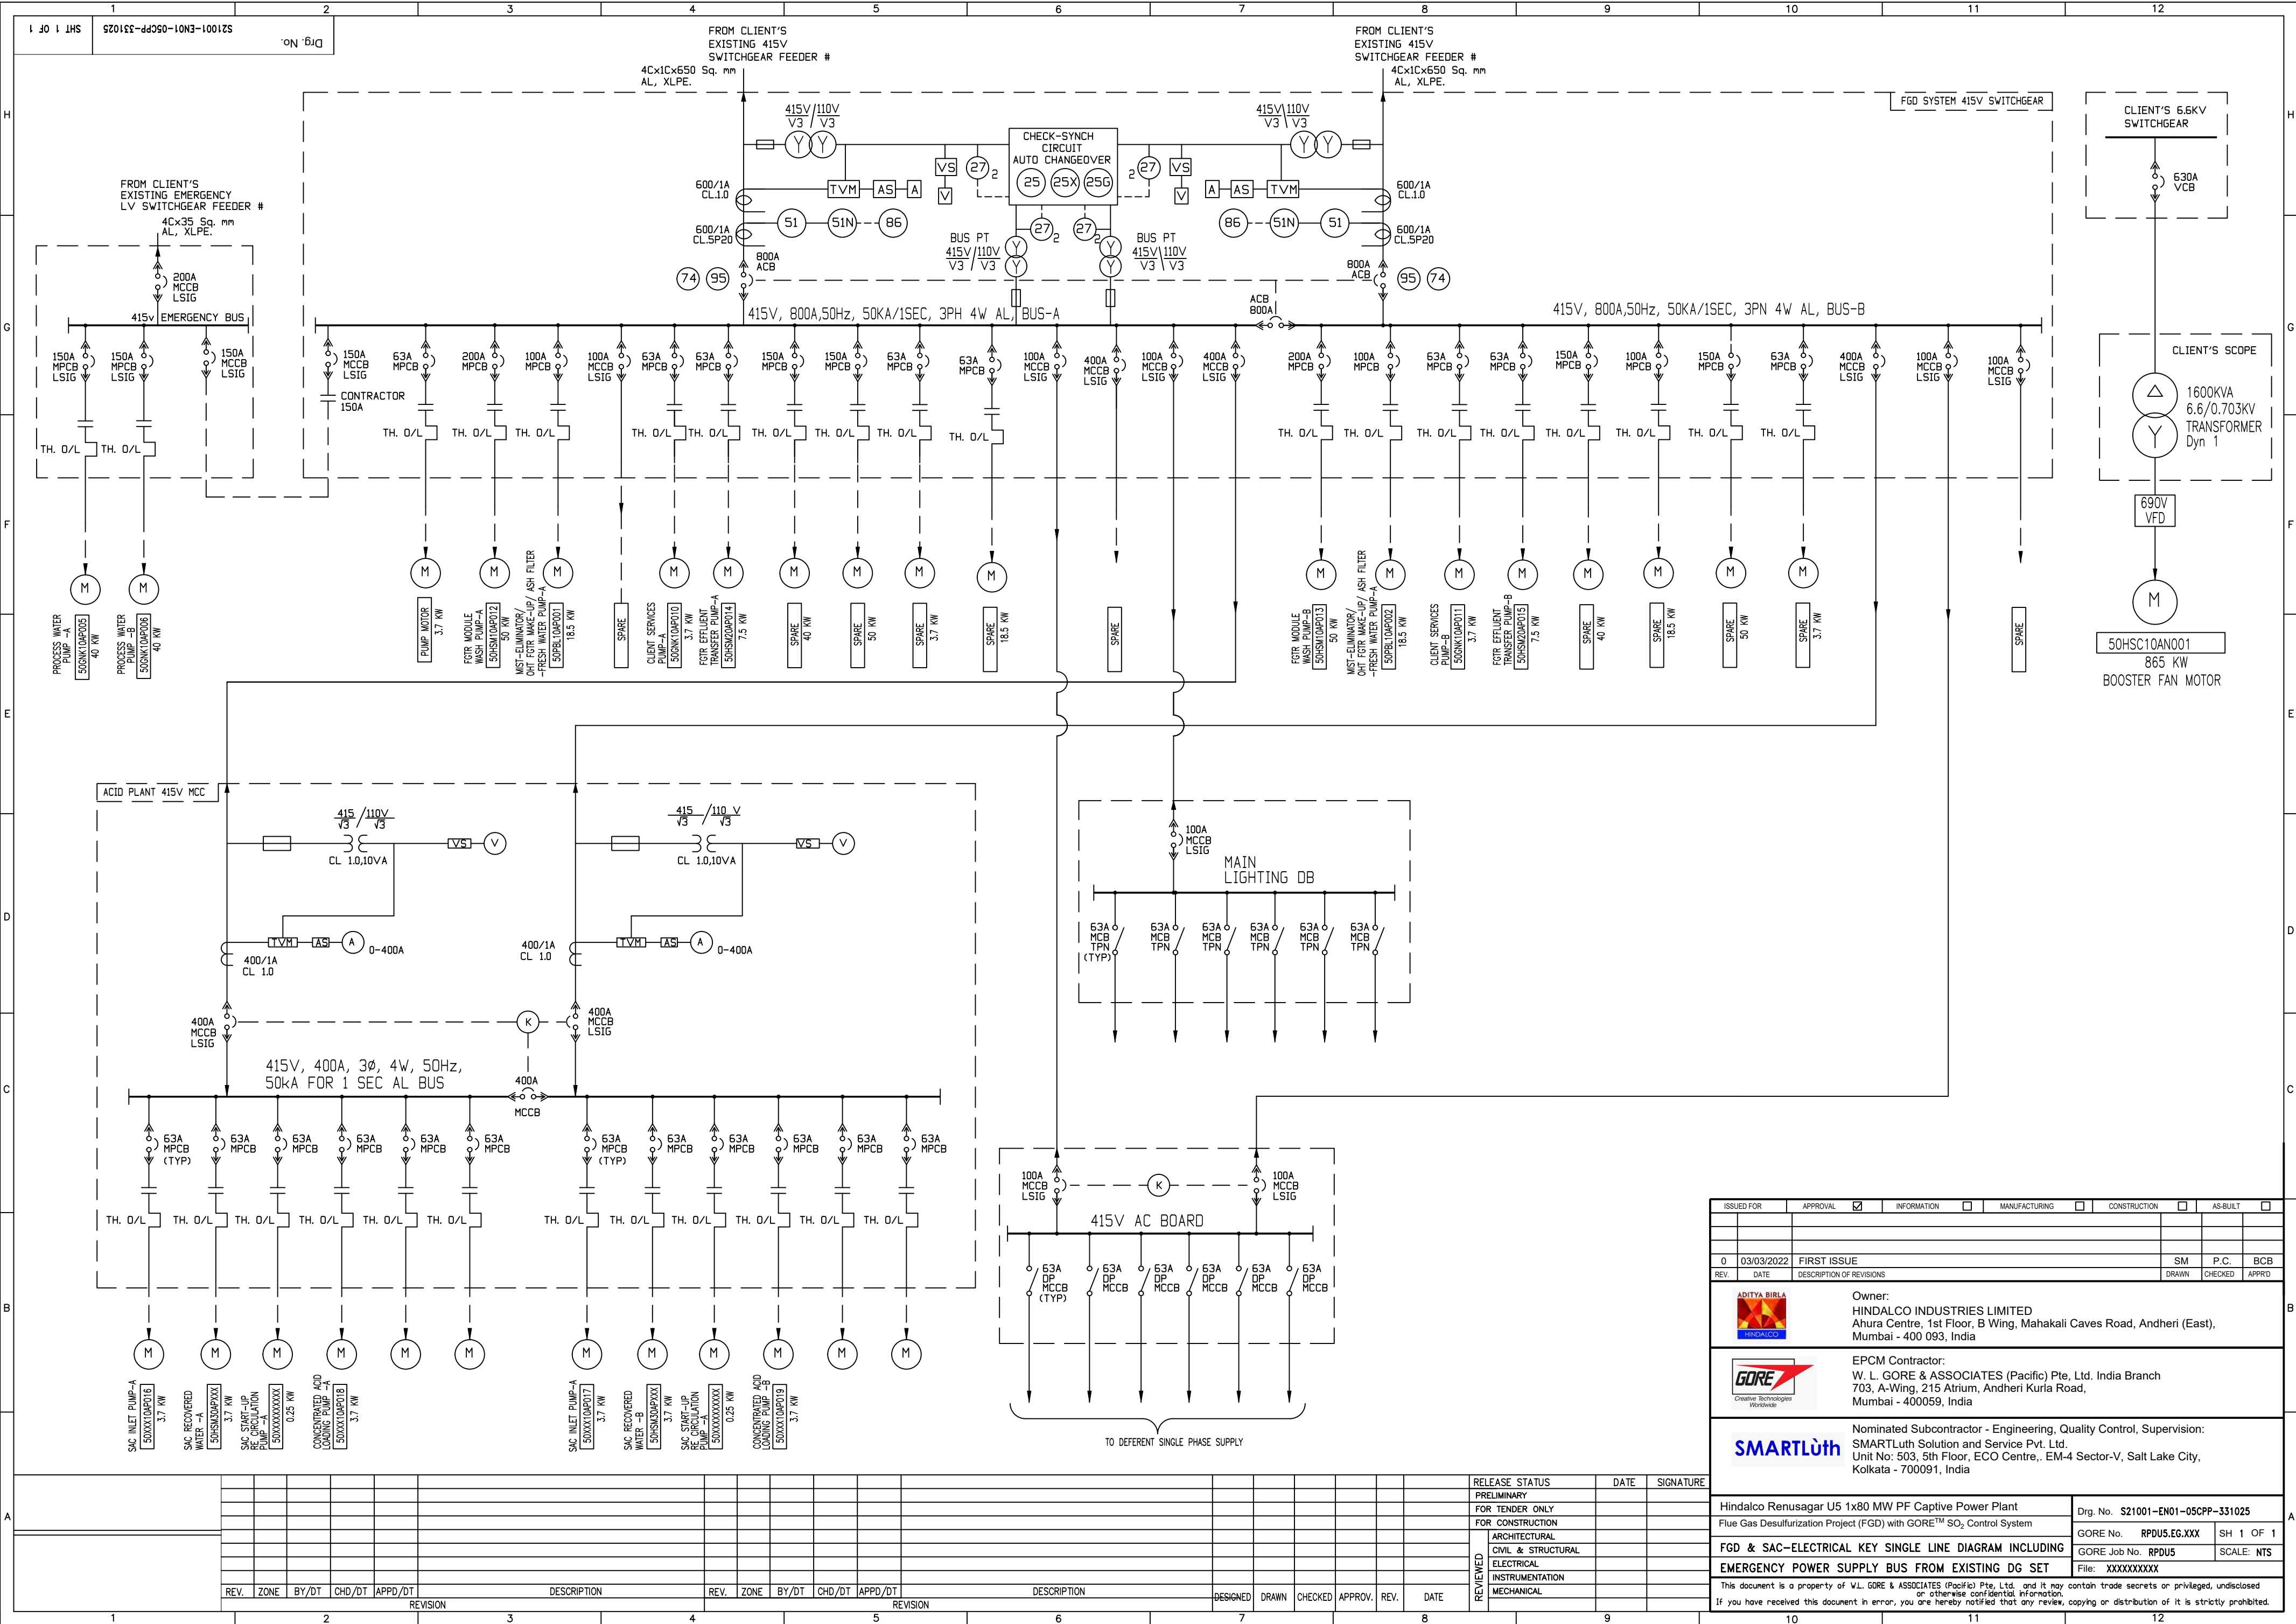

ISSUED FOR		APPROVAL	INFORMATION	MANUFACTURING	CONSTRUCTION	AS-BUILT		
		☒	☐	☐	☐	☐		
0	03/03/2022	FIRST ISSUE				SM	P.C.	BCB
REV.	DATE	DESCRIPTION OF REVISIONS				DRAWN	CHECKED	APPROD.
		Owner: HINDALCO INDUSTRIES LIMITED Ahura Centre, 1st Floor, B Wing, Mahakali Caves Road, Andheri (East), Mumbai - 400 093, India						
		EPCM Contractor: W. L. GORE & ASSOCIATES (Pacific) Pte. Ltd. India Branch 703, A-Wing, 215 Atrium, Andheri Kurla Road, Mumbai - 400059, India						
		Nominated Subcontractor - Engineering, Quality Control, Supervision: SMARTLuth Solution and Service Pvt. Ltd. Unit No: 503, 5th Floor, ECO Centre., EM-4 Sector-V, Salt Lake City, Kolkata - 700091, India						
Hindalco Renusagar U5 1x80 MW PF Captive Power Plant						Drg. No. S21001-EN01-05CPP-331025		
Flue Gas Desulfurization Project (FGD) with GORE™ SO ₂ Control System						GORE No. RPDUS.EG.XXX		SH 1 OF 1
FGD & SAC-ELECTRICAL KEY SINGLE LINE DIAGRAM INCLUDING						GORE Job No. RPDUS		SCALE: NTS
EMERGENCY POWER SUPPLY BUS FROM EXISTING DG SET						File: XXXXXXXXXX		
This document is a property of W.L. GORE & ASSOCIATES (Pacific) Pte. Ltd. and it may contain trade secrets or privileged, undisclosed or otherwise confidential information. If you have received this document in error, you are hereby notified that any review, copying or distribution of it is strictly prohibited.								