


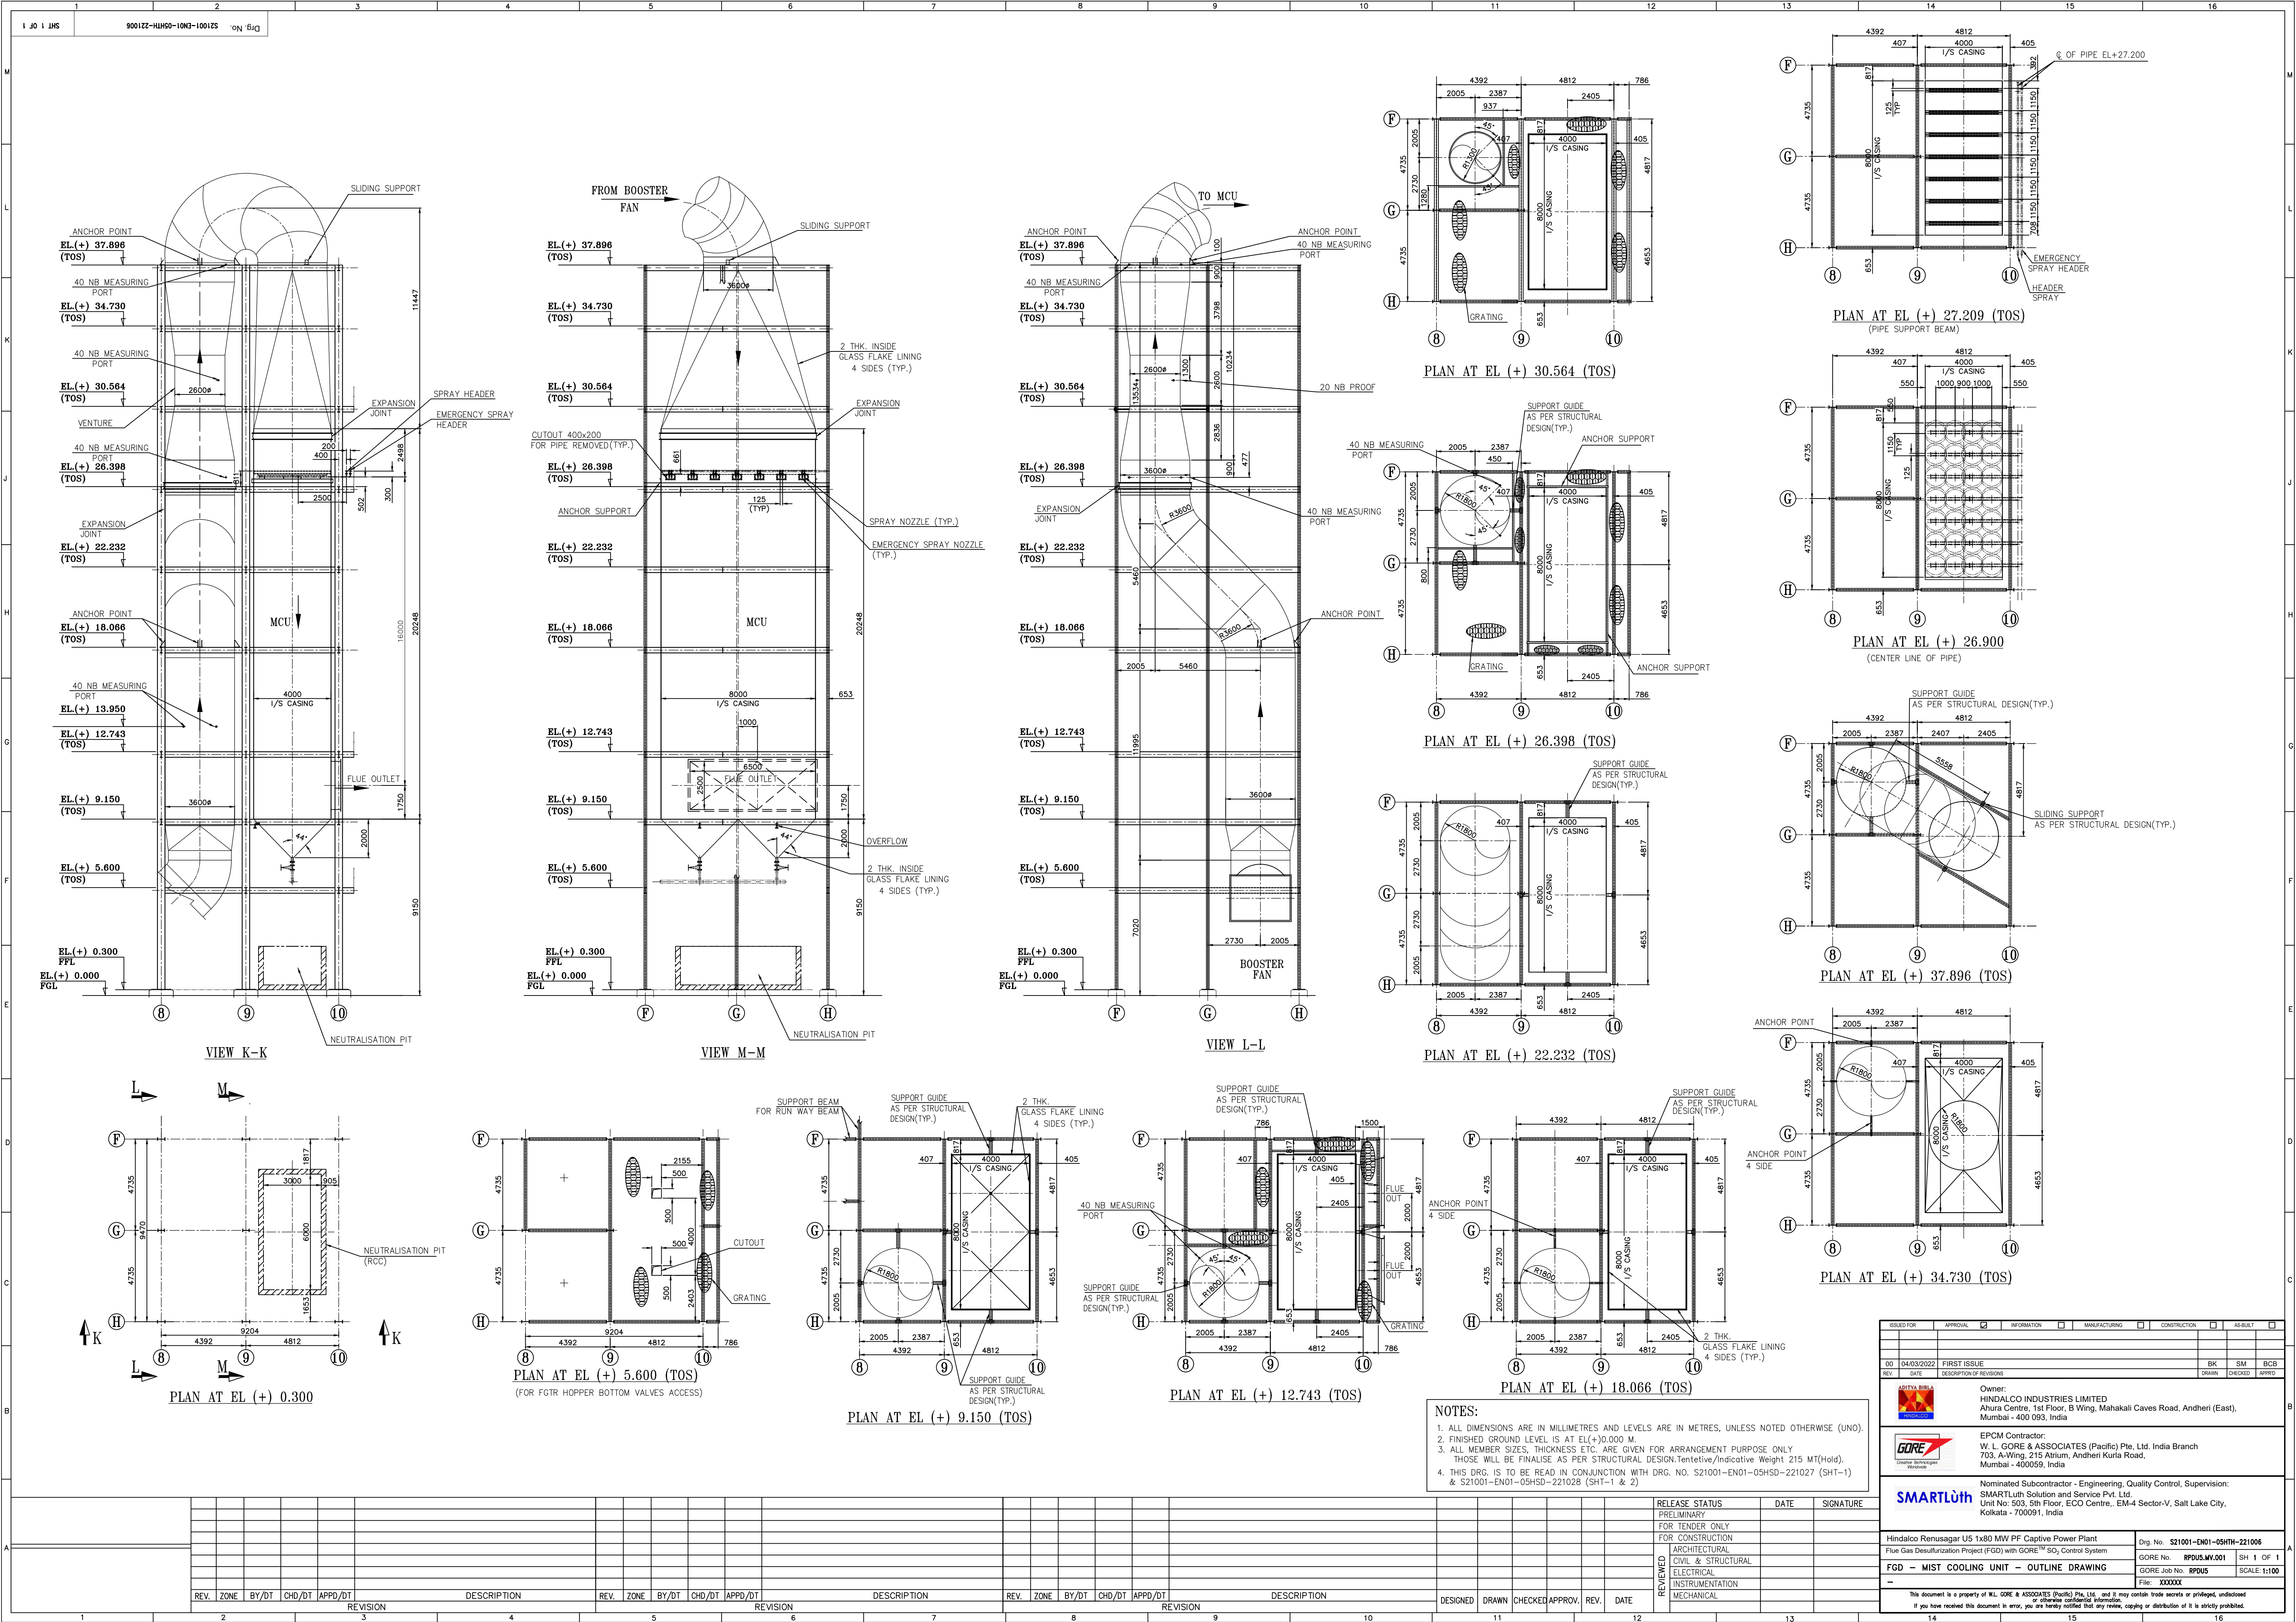

ISSUED FOR	APPROVAL	INFORMATION	MANUFACTURING	CONSTRUCTION	AS-BUILT
00	04/03/2022	FIRST ISSUE			
REV	DATE	DESCRIPTION OF REVISION	BK	SM	BCB
01	04/03/2022	Owner: HINDALCO INDUSTRIES LIMITED Ahura Centre, 1st Floor, B Wing, Mahakali Caves Road, Andheri (East), Mumbai - 400 093, India			
02	04/03/2022	EPCM Contractor: W. L. GORE & ASSOCIATES (PACIFIC) Pte. Ltd. India Branch 703, A-Wing, 215 Atrium, Andheri Kuria Road, Mumbai - 400058, India			
03	04/03/2022	Nominated Subcontractor - Engineering, Quality Control, Supervision: SMARTLuth Solution and Service Pvt. Ltd. Unit No. 503, 5th Floor, ECO Centre, EM-4 Sector-V, Salt Lake City, Kolkata - 700091, India			
04	04/03/2022	Hindalco RenuSagar U5 1x80 MW PF Captive Power Plant Flue Gas Desulfurization Project (FGD) with GORE™ SO ₂ Control System			
05	04/03/2022	FGD - MIST COOLING UNIT - OUTLINE DRAWING			
06	04/03/2022	Drawn by: RPDUS.MW.001 Checked by: RPDUS			
07	04/03/2022	Scale: 1:100			
08	04/03/2022	This document is a property of W. L. GORE & ASSOCIATES (PACIFIC) Pte. Ltd. and it may contain trade secrets or privileged, undisclosed or otherwise confidential information. If you have received this document in error, you are hereby notified that any review, copying or distribution of it is strictly prohibited.			