

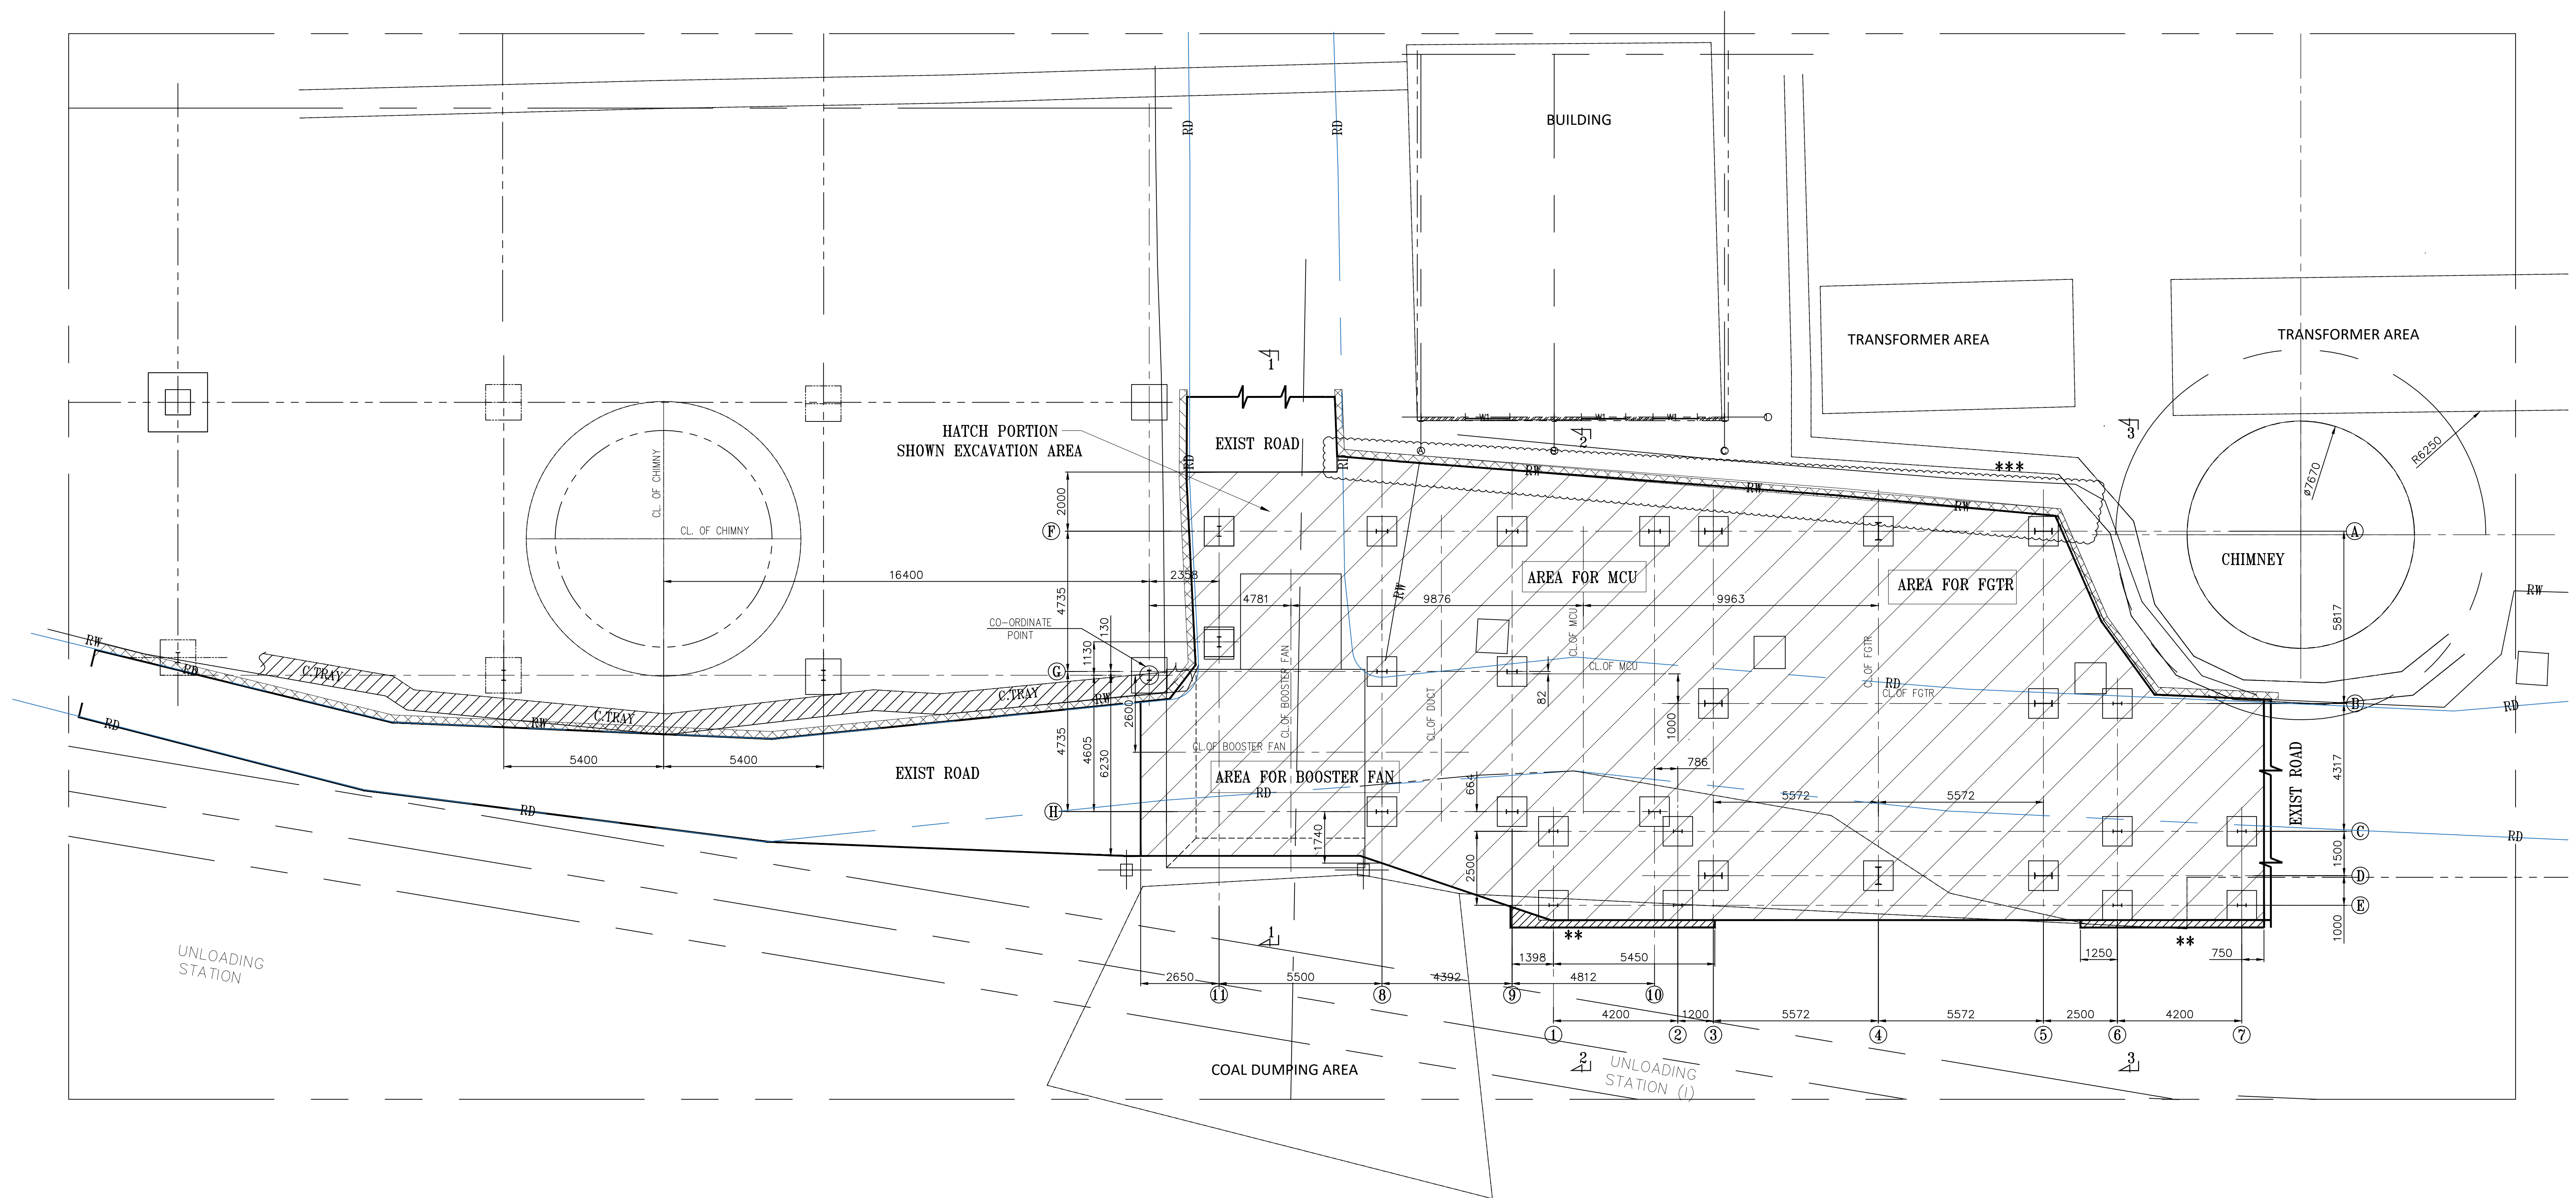
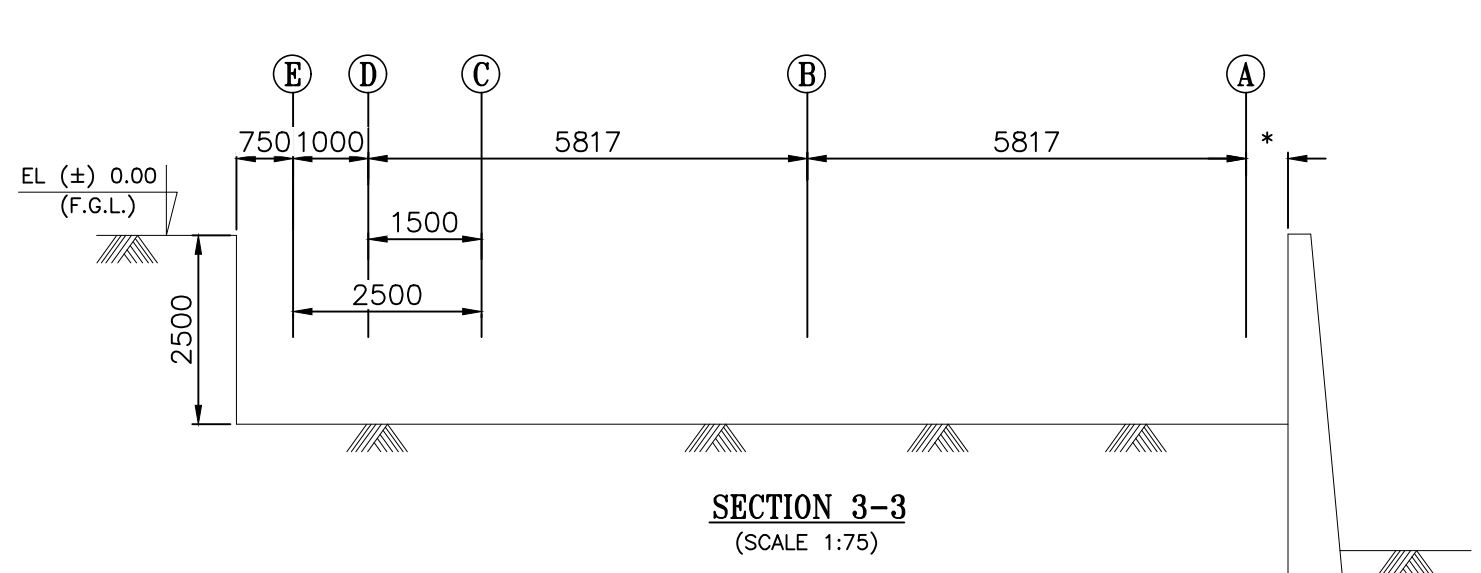


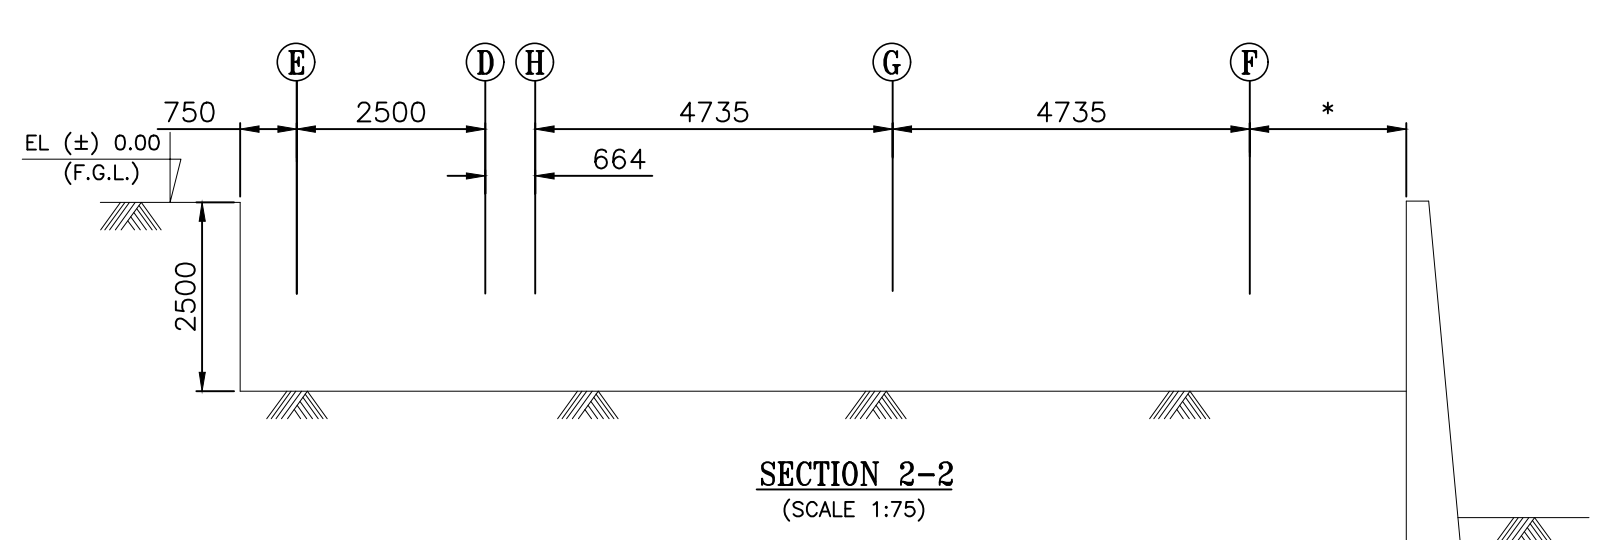

* IN THESE AREA DIMENSION IS VARYING
** IN THESE AREA ALSO BE EXCAVATE.
*** EXCAVATION SHALL BE DONE UP TO THE RETAINING WALL AS MARKED.
HOWEVER, FOUNDATION RAFT MAY GO BEYOND THE RETAINING WALL & THIS EXPOSED RAFT BEYOND RETAINING WALL MUST BE PROPERLY SUPPORTED FORM THOSE AREA GROUND LEVEL.

APPROX. CUTTING VOLUME = 1132 M³

- NOTES:-
1. ALL DIMENSIONS ARE IN M.M. AND LEVELS IN M.
 2. EL.(+/-)0.00 CORRESPONDS TO RL +276.0M.
 3. THIS DRG. IS PREPARED BASED ON DRG. NO. S21001-EN01-05HSD-221027
 4. DUE TO SPACE CONSTRAINT, MANUAL EXCAVATION IS TO BE CARRIED OUT AFTER SHORT BLASTING(F REQUIRE).
 5. FOR CO ORDINATE OR REFERENCE GRID REFER ABOVE NOTE NO. 3
 6. AS PER PRESENT AVAILABLE DATA THE MAXIMUM FOUNDING DEPTH CONSIDERED AS RL + 273.5M AND THIS EXCAVATION LAYOUT PREPARED ACCORDINGLY. HOWEVER SUITABLE MODIFICATION MAY BE REQUIRED AS PER ACTUAL CONDITIONS.
 7. FOR TOPOGRAPHY OF SITE REFER DRG PREPARED BY M/S GLOBAL SURVEYORS.
 7. SUITABLE DEWATERING ARRANGEMENT TO BE KEPT AS PER SITE REQUIREMENT.

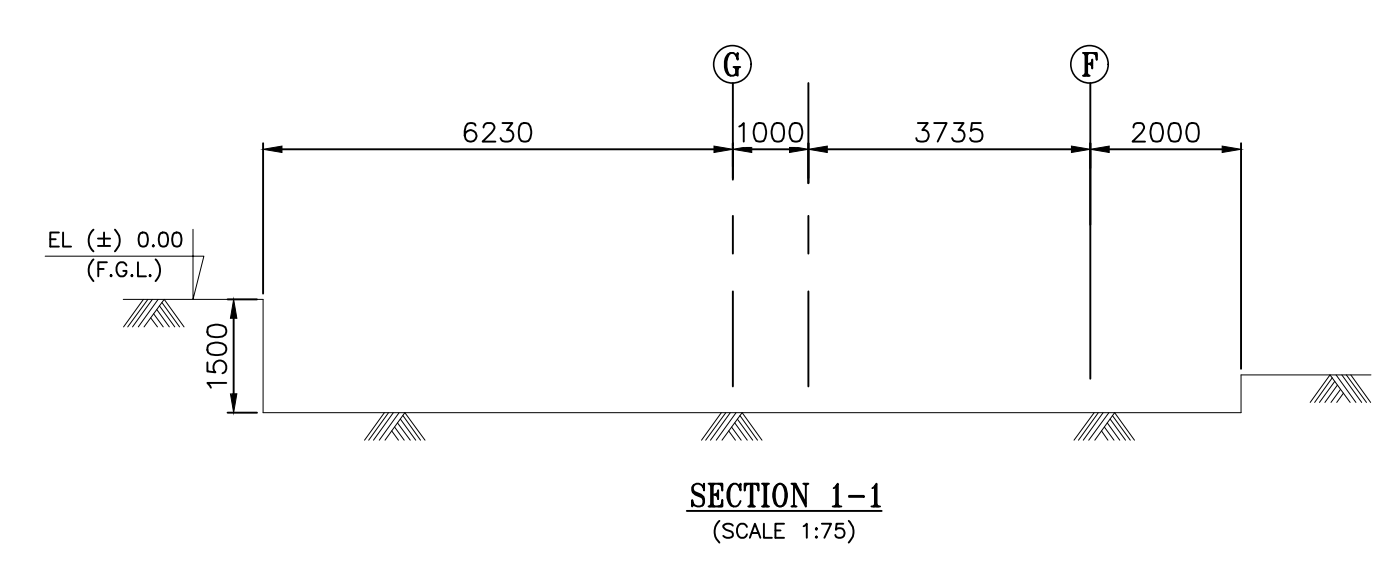

REV.	ZONE	BY/DT	CHD/DT	APPD/DT	REVISION	DESCRIPTION	REV.	ZONE	BY/DT	CHD/DT	APPD/DT	REVISION	DESCRIPTION	REV.	ZONE	BY/DT	CHD/DT	APPD/DT	REVISION	DESCRIPTION	DESIGNED	DRAWN	CHECKED	APPROV.	REV.	DATE

ISSUED FOR	APPROVAL	INFORMATION	MANUFACTURING	CONSTRUCTION	AS-BUILT	
0	17-3-2022	Initial Release		SM	IR	BCB
REV.	DATE	DESCRIPTION OF REVISIONS		DRAWN	CHECKED	APPROV.
		Owner: HINDALCO INDUSTRIES LIMITED Ahura Centre, 1st Floor, B Wing, Mahakali Caves Road, Andheri (East), Mumbai - 400 083, India				
		EPCM Contractor: W. L. GORE & ASSOCIATES (Pacific) Pte. Ltd. India Branch 703, A-Wing, 215 Atrium, Andheri Kurla Road, Mumbai - 400059, India				
		Nominated Subcontractor - Engineering, Quality Control, Supervision: SMARTLuth Solution and Service Pvt. Ltd. Unit No: 503, 5th Floor, ECO Centre., EM-4 Sector-V, Salt Lake City, Kolkata - 700091, India				
Hindalco Renuagar US 1x80 MW PF Captive Power Plant Flue Gas Desulfurization Project (FGD) with GORE™ SO ₂ Control System			Drg No. S21001-EN01-05CPP-551003			
FGD & SAC-Excavation & backfilling's (with bill of quantities)			GORE No. RPDUS.MC.503 SH 1 OF 1 GORE Job No. RPDUS SCALE: 1:100			
This document is a property of W.L. GORE & ASSOCIATES (Pacific) Pte. Ltd. and it may contain trade secrets or privileged, undisclosed or otherwise confidential information. If you have received this document in error, you are hereby notified that any review, copying or distribution of it is strictly prohibited.						